

NEW STATION DEWITT FIRE DISTRICT

4500 E. GENESEE STREET
DEWITT NY, 13214

DEWITT FIRE STATION



www.bergmannpc.com

28 East Main Street
200 First Federal Plaza
Rochester, New York 14614
585.232.5135 / 585.232.4652 fax

Engineers / Architects / Planners / Surveyors

REVISIONS			
NO.	DATE	DESCRIPTION	REV. CK'D

NOTE:
Unauthorized alteration or addition to this drawing is a violation of the New York State Education Law Article 145, Section 7209.

SCHEME 10

FIRST FLOOR PLAN


Project Manager:
A. PETROSKY
Designed by:
A. PETROSKY
Drawn by:
L. MCMULLEN
Checked by:
T. GARTELEIN
Date Issued:
NOVEMBER 14, 2006
Scale:

Date: _____
Project Number: _____ File Name: _____

Drawing Number:

A102

X of 71

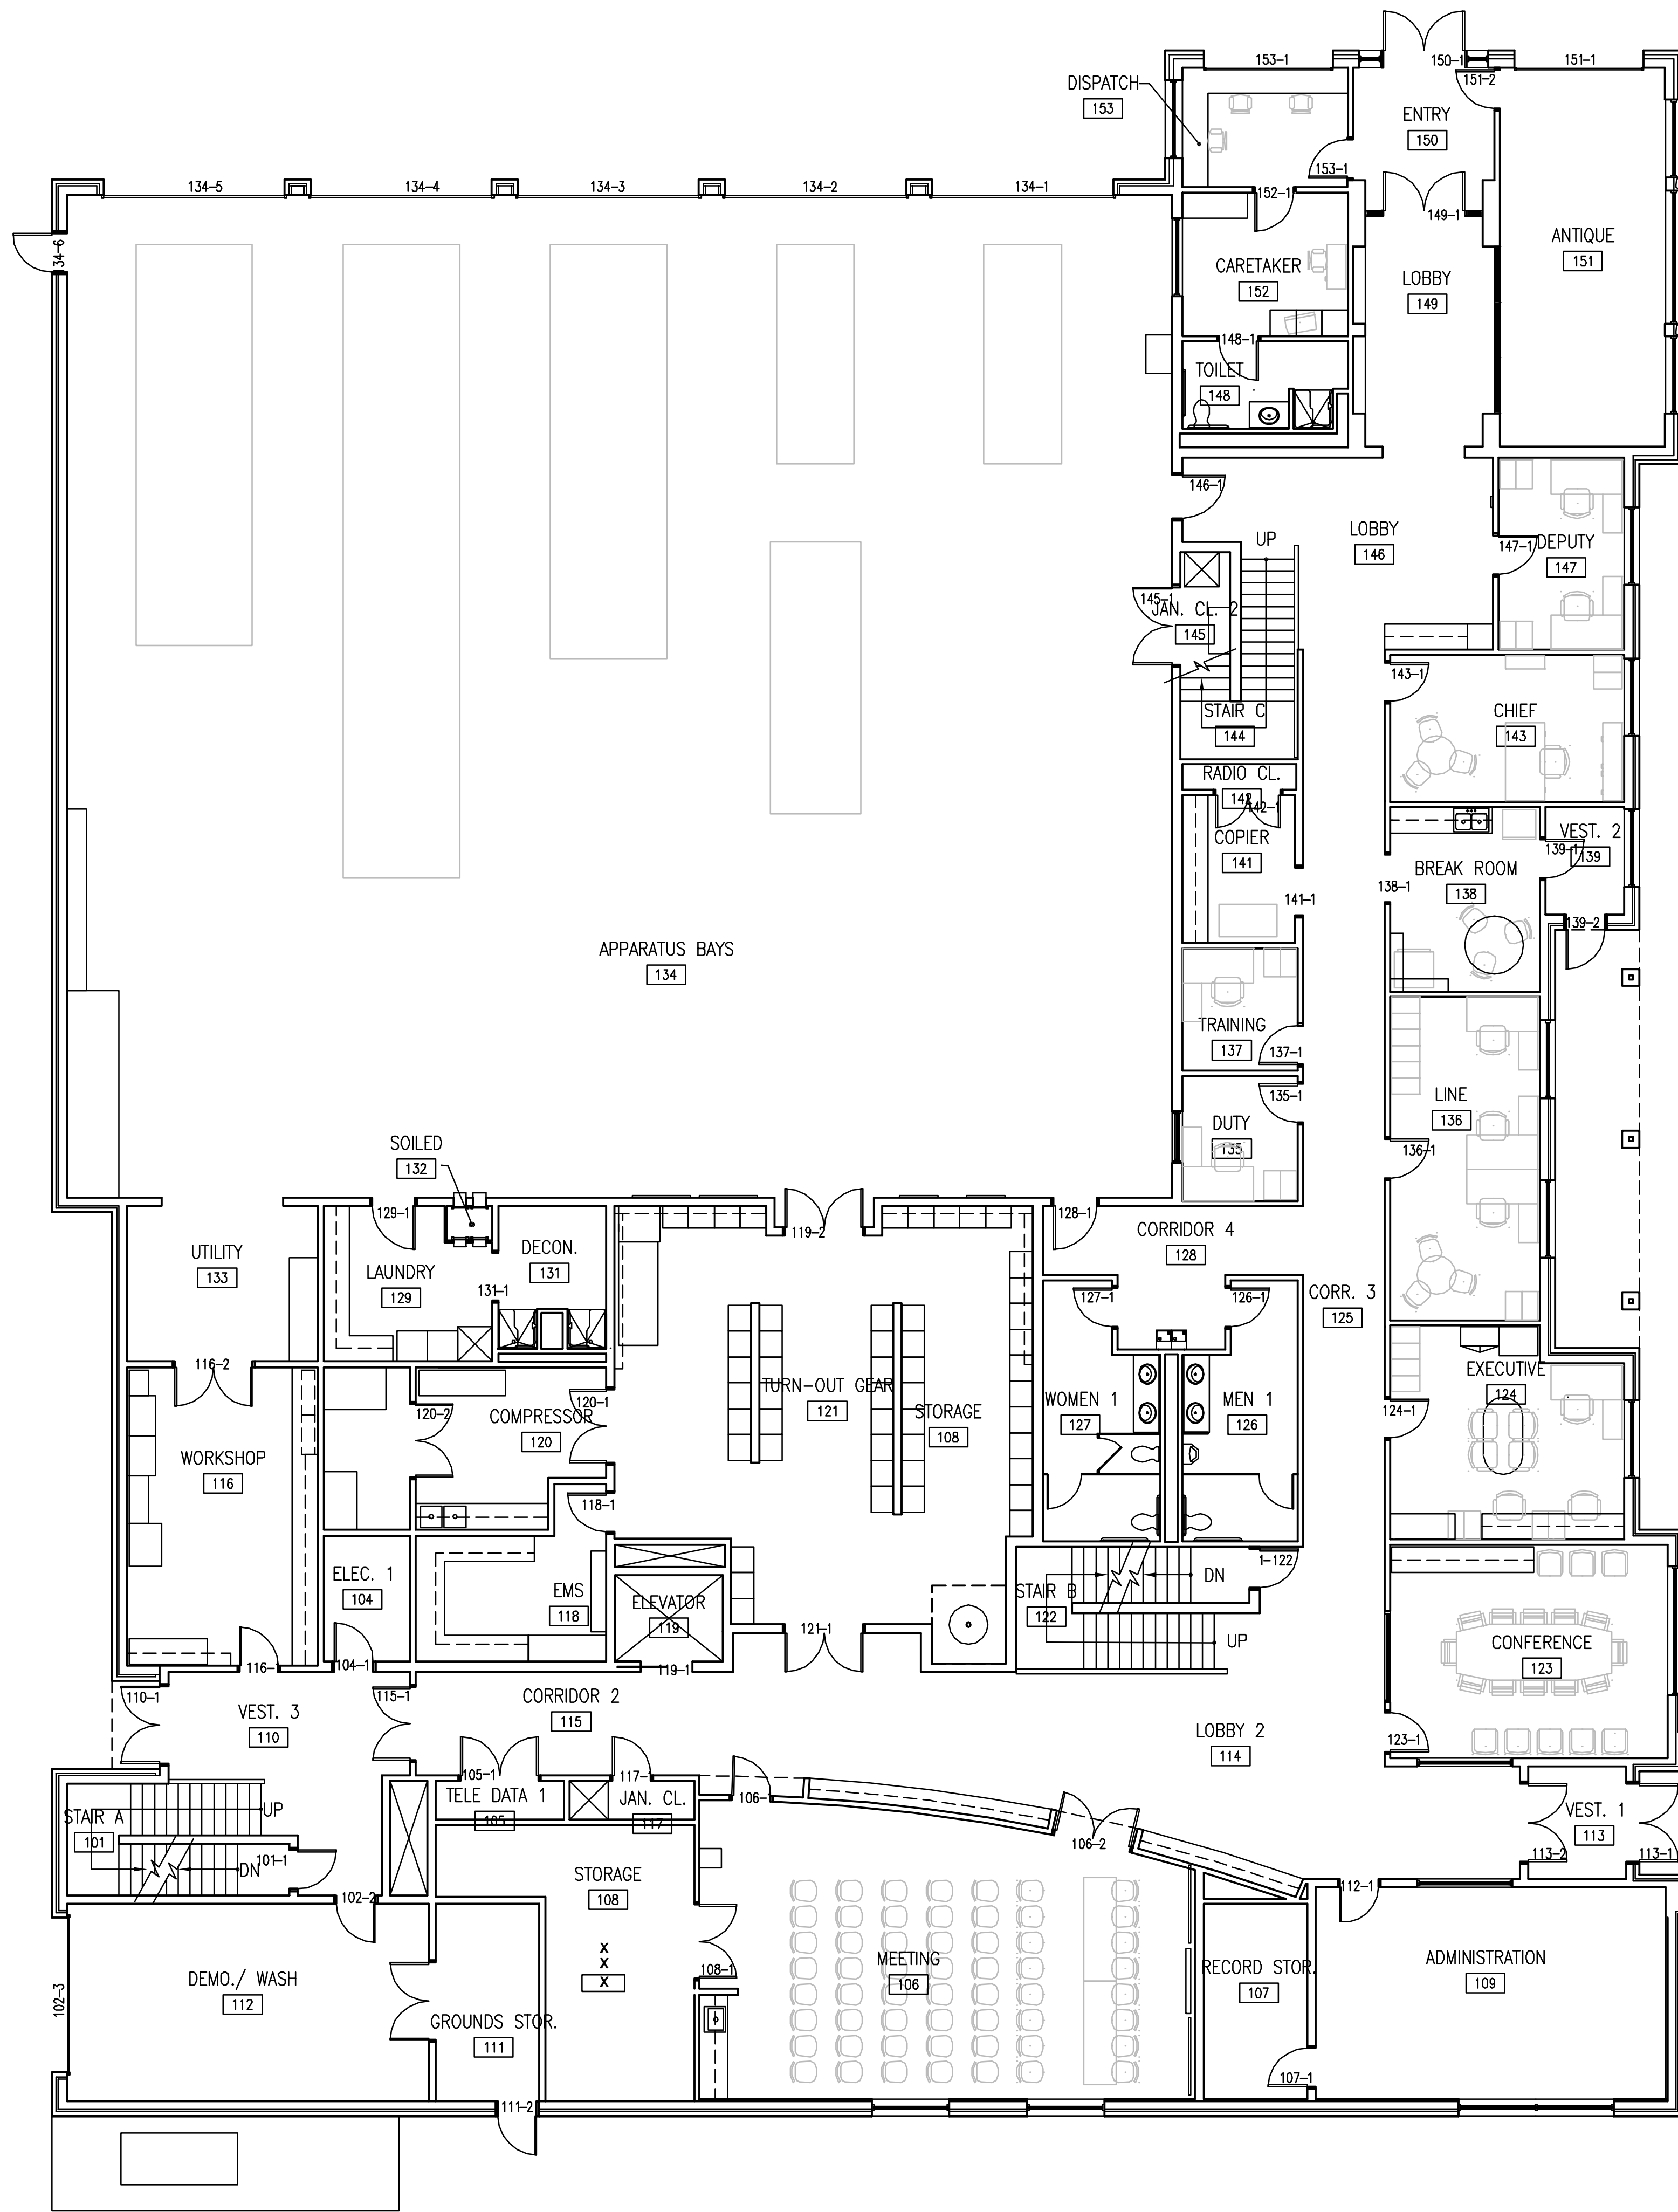

FIRST FLOOR PLAN
SCALE: 1/8"=1'-0"

