

# NEW STATION DEWITT FIRE DISTRICT

4500 E. GENESEE STREET  
DEWITT NY, 13214

## DEWITT FIRE STATION



www.bergmannpc.com

28 East Main Street  
200 First Federal Plaza  
Rochester, New York 14614  
585.232.5135 / 585.232.4652 fax

Engineers / Architects / Planners / Surveyors

REVISIONS

NO.	DATE	DESCRIPTION	REV.	CK'D

NOTE:  
Unauthorized alteration or addition to this drawing is a violation of the New York State Education Law Article 145, Section 7209.

## SCHEME 10


### SECOND FLOOR PLAN

Project Manager:  
**A. PETROSKY**  
Designed by:  
**A. PETROSKY**  
Drawn by:  
**L. McMULLEN**  
Checked by:  
**T. GASTELIN**  
Date Issued:  
NOVEMBER 14, 2006  
Scale:

Date: \_\_\_\_\_  
Project Number: \_\_\_\_\_ File Name: \_\_\_\_\_

Drawing Number:

# A103

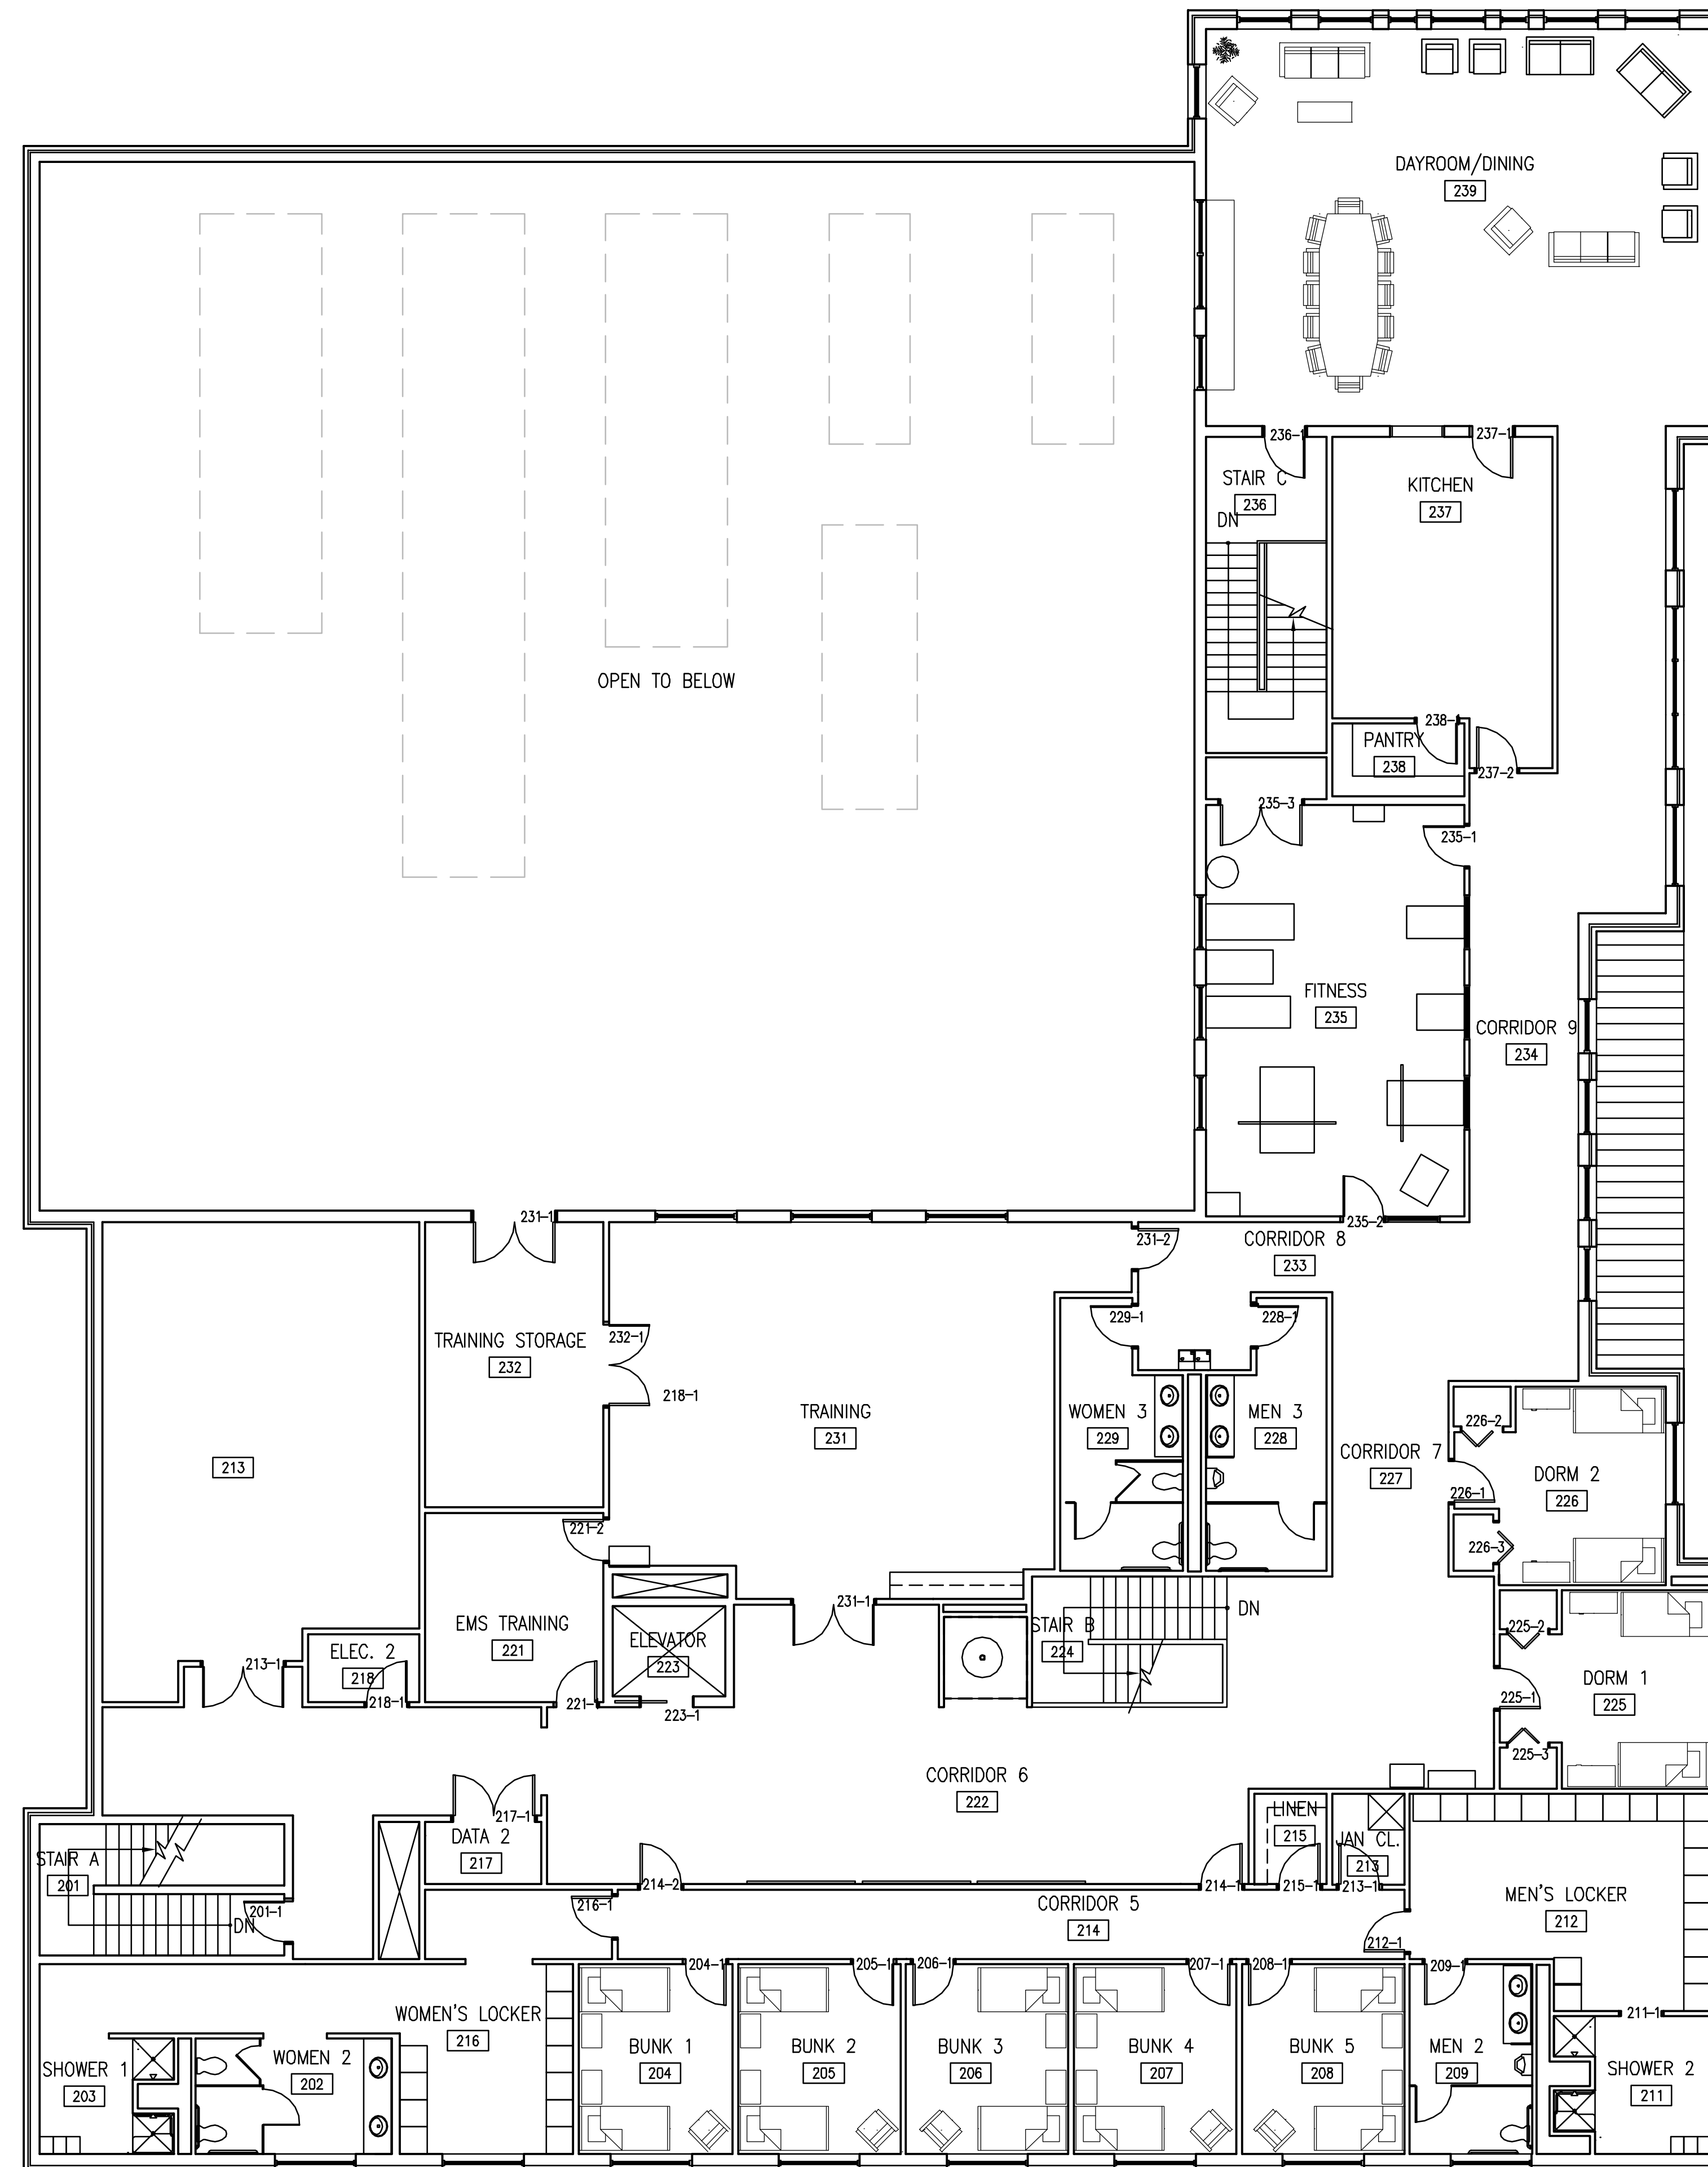

### SECOND FLOOR PLAN

SCALE: 1/8"=1'-0"

